


1
FP-3

NORTH BUILDING FIRST FLOOR PLAN – SPRINKLER

A & J PROJ. No. 826

A&J Consulting
Engineering Services, P.C.
 164 Brighton Road, Clifton, NJ 07012
 T: 973-777-9696 | F: 973-777-5528
 W: anjengineer.com

Kearny Board of Education AIRCRAFT NOISE ABATEMENT PROGRAM 336 DEVON STREET KEARNY, NJ 07032				
NORTH BUILDING FIRST FLOOR PLAN – SPRINKLER ADDENDUM NO.1				
BY: WS	SCALE: 1/16"=1'-0"	DATE 8/26/10	REF. DWG. FP-3	SKETCH No. SK-FP-1

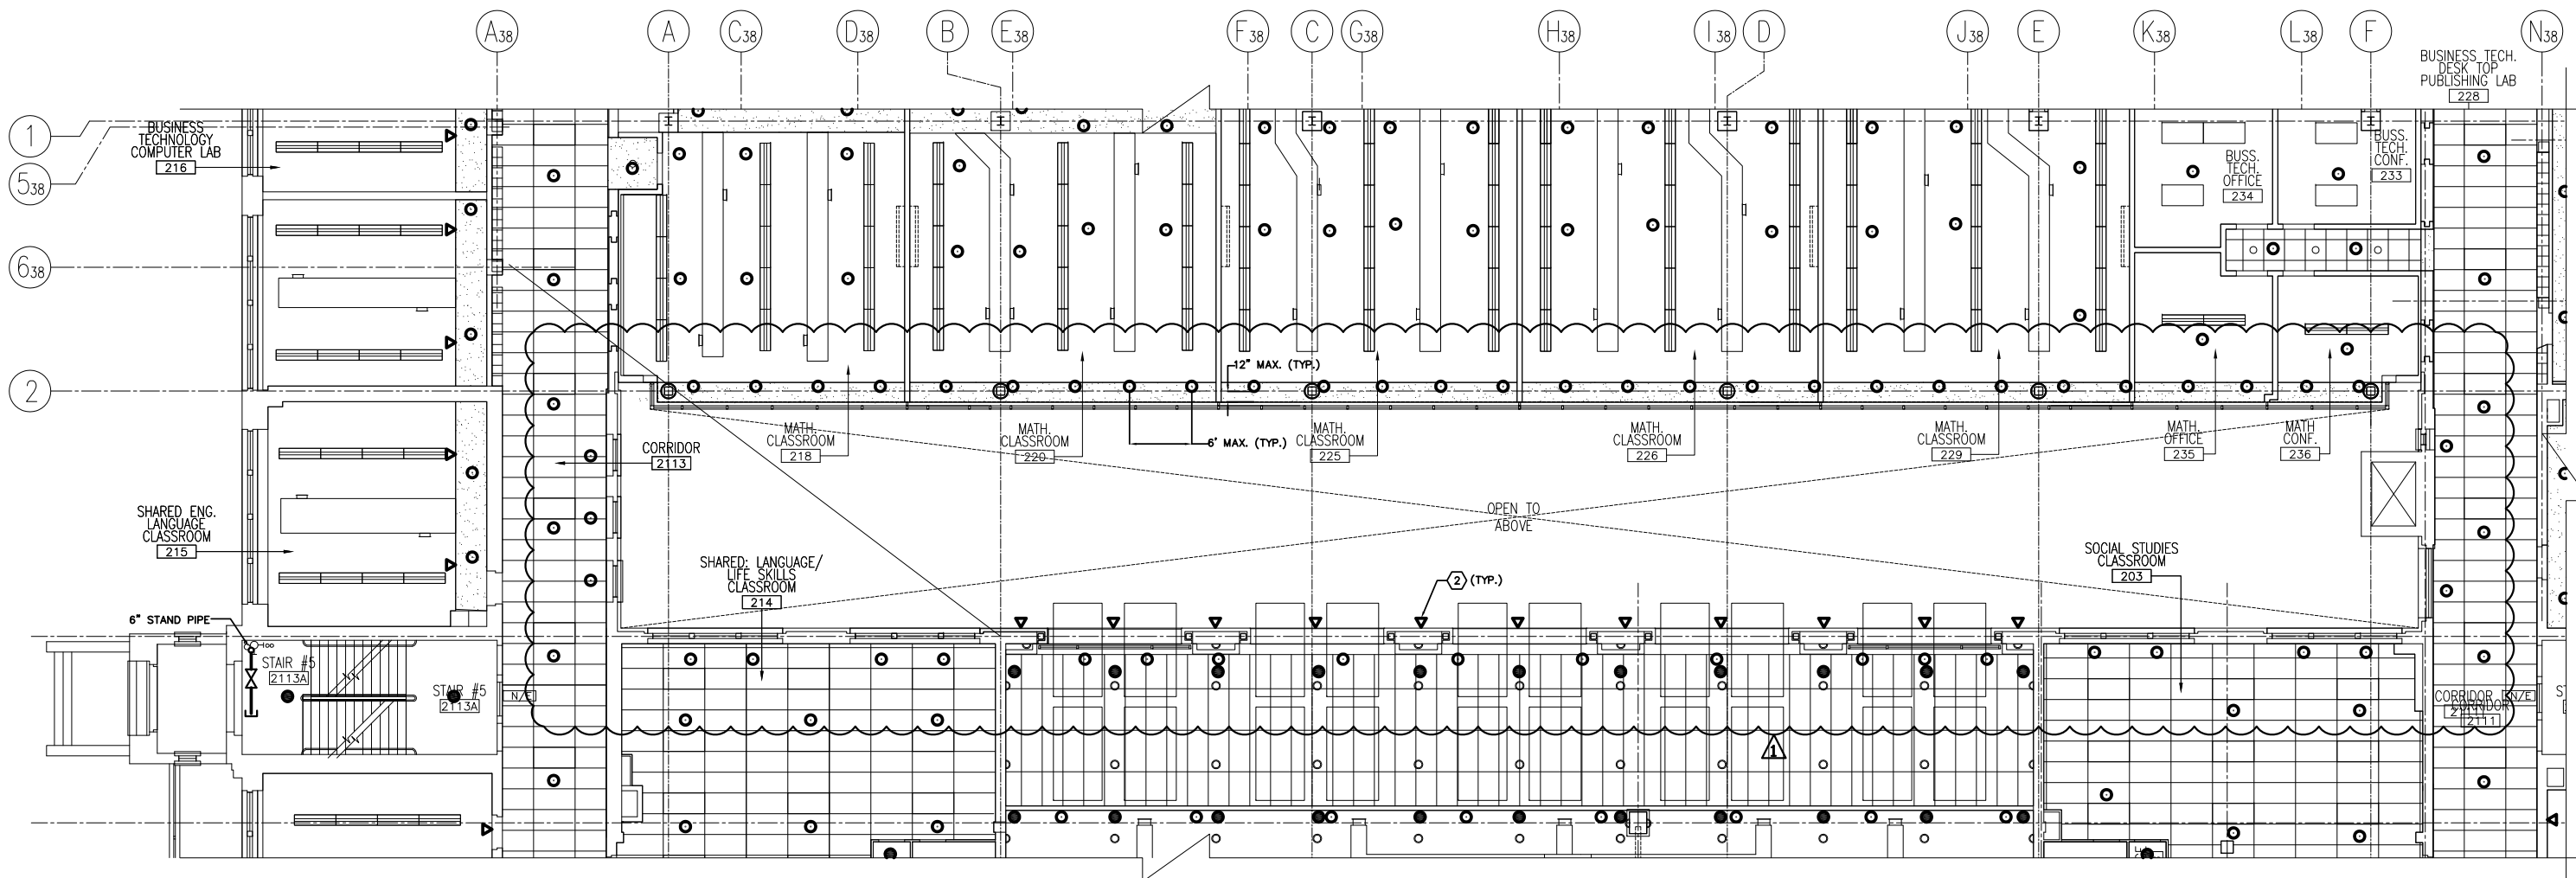


1 NORTH BUILDING SECOND FLOOR PLAN – SPRINKLER
 FP-4

A & J PROJ. No. 826

A&J Consulting
 Engineering Services, P.C.
 164 Brighton Road, Clifton, NJ 07012
 T: 973-777-9696 | F: 973-777-5528
 W: anjengineer.com

Kearny Board of Education AIRCRAFT NOISE ABATEMENT PROGRAM 336 DEVON STREET KEARNY, NJ 07032				
NORTH BUILDING SECOND FLOOR PLAN – SPRINKLER ADDENDUM NO.1				
BY: WS	SCALE: 1/16"=1'-0"	DATE 8/26/10	REF. DWG. FP-4	SKETCH No. SK-FP-2

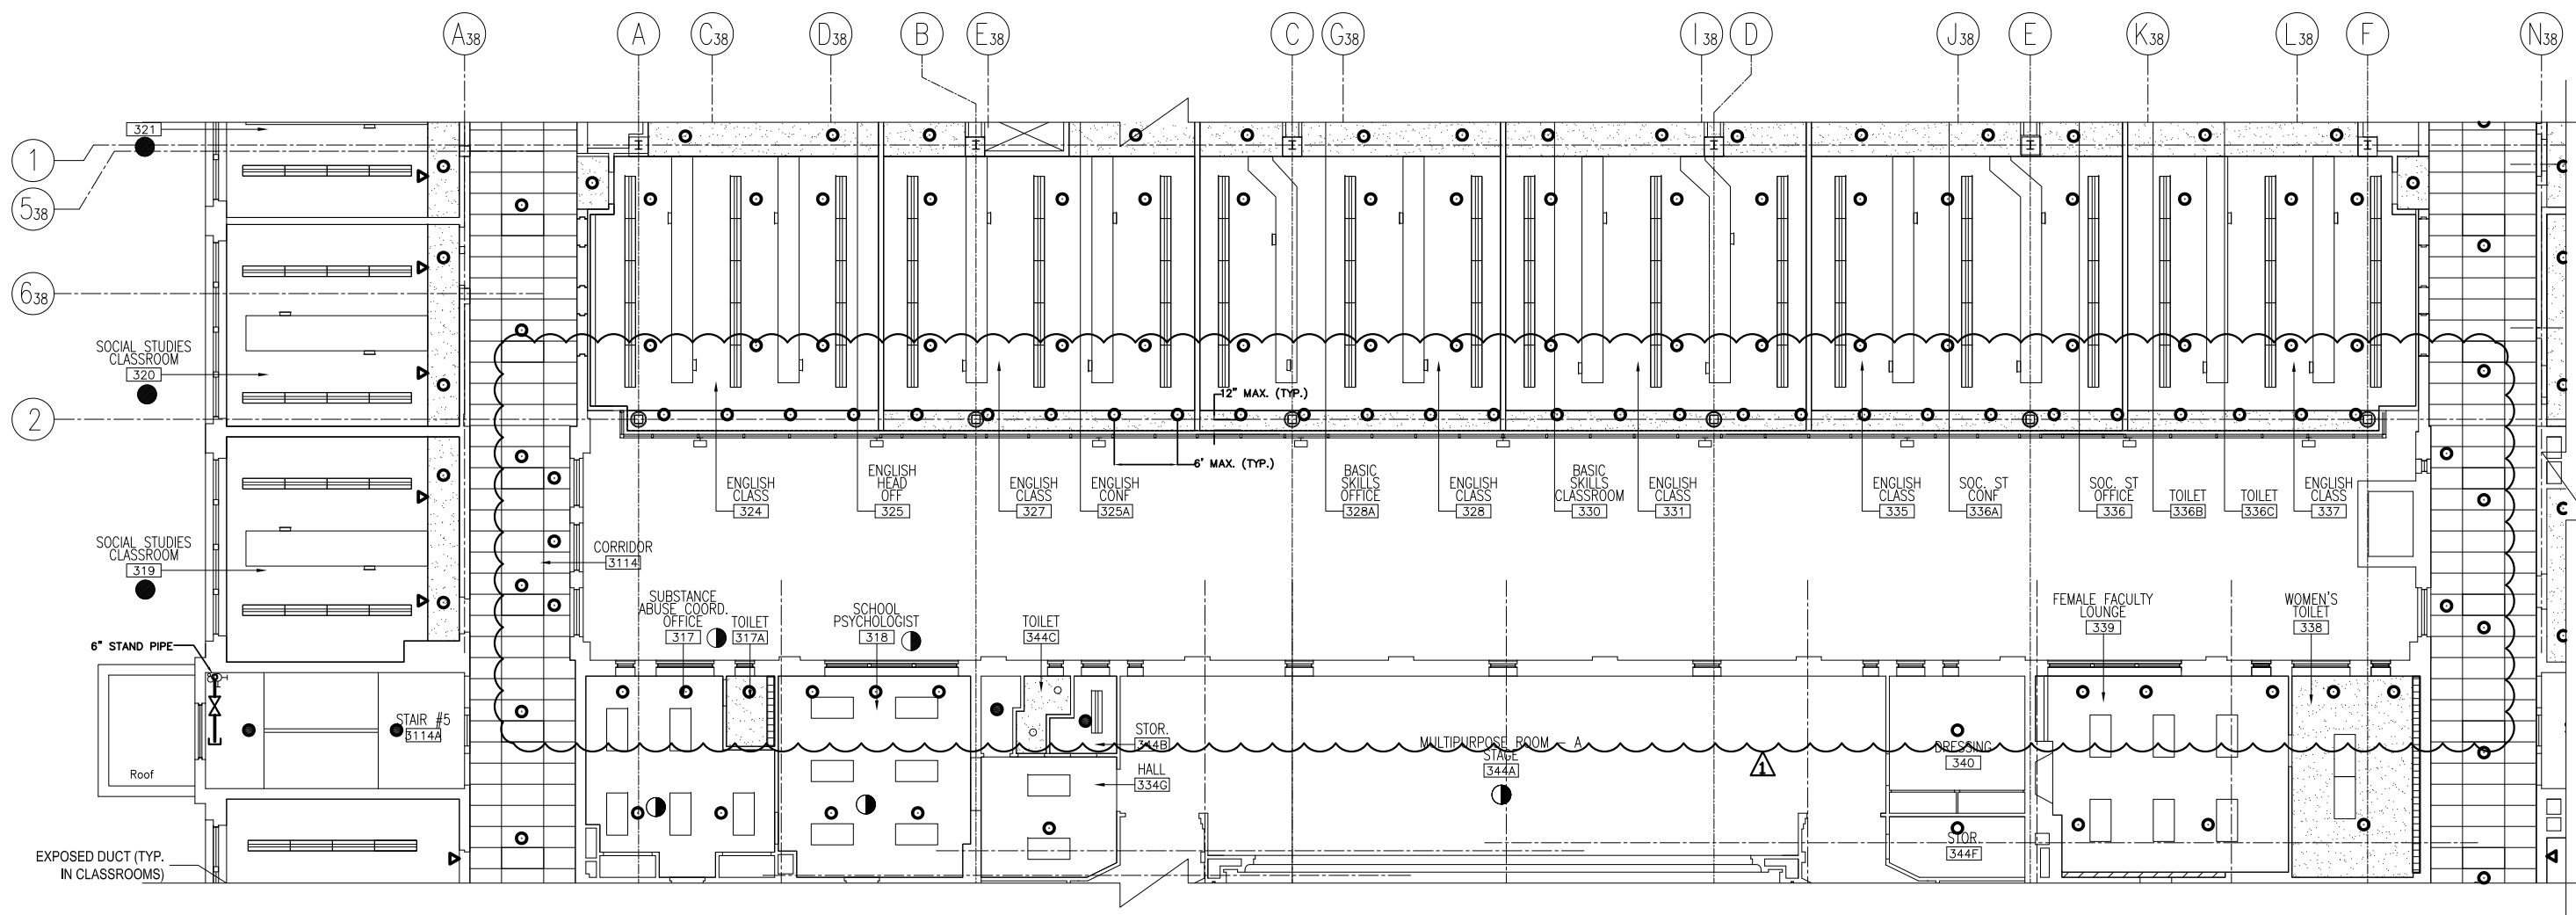


1
FP-5

NORTH BUILDING THIRD FLOOR PLAN – SPRINKLER

A & J PROJ. No. 826

A&J Consulting
Engineering Services, P.C.
 164 Brighton Road, Clifton, NJ 07012
 T: 973-777-9696 | F: 973-777-5528
 W: anjengineer.com

Kearny Board of Education AIRCRAFT NOISE ABATEMENT PROGRAM 336 DEVON STREET KEARNY, NJ 07032				
NORTH BUILDING THIRD FLOOR PLAN – SPRINKLER ADDENDUM NO.1				
BY: WS	SCALE: 1/16"=1'-0"	DATE 8/26/10	REF. DWG. FP-5	SKETCH No. SK-FP-3

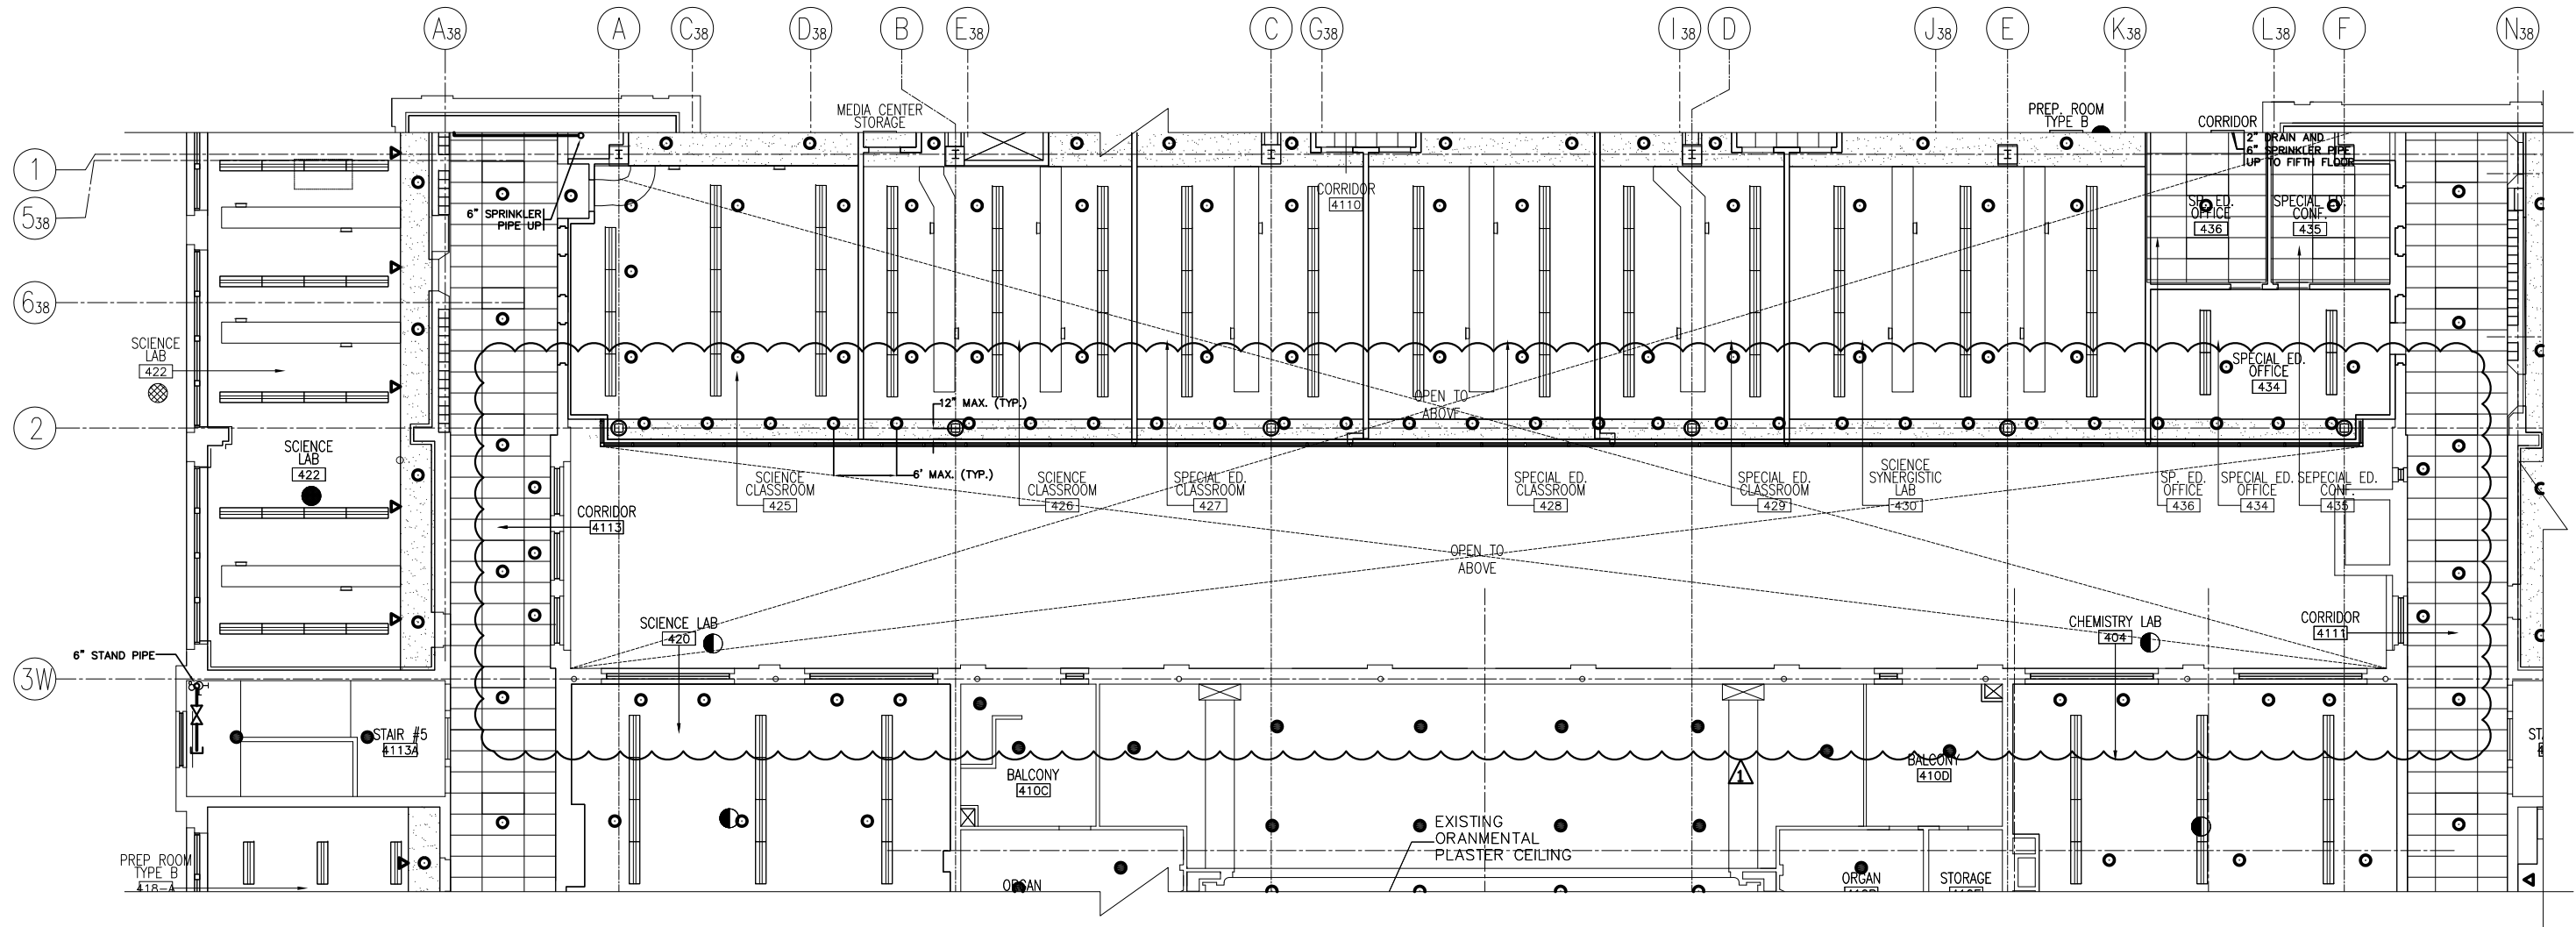

1 NORTH BUILDING FOURTH FLOOR PLAN – SPRINKLER
 FP-6

A & J PROJ. No. 826

A&J Consulting
 Engineering Services, P.C.
 164 Brighton Road, Clifton, NJ 07012
 T: 973-777-9696 | F: 973-777-5528
 W: anjengineer.com

Kearny Board of Education AIRCRAFT NOISE ABATEMENT PROGRAM 336 DEVON STREET KEARNY, NJ 07032				
NORTH BUILDING FOURTH FLOOR PLAN – SPRINKLER ADDENDUM NO.1				
BY: WS	SCALE: 1/16"=1'-0"	DATE 8/26/10	REF. DWG. FP-6	SKETCH No. SK-FP-4